


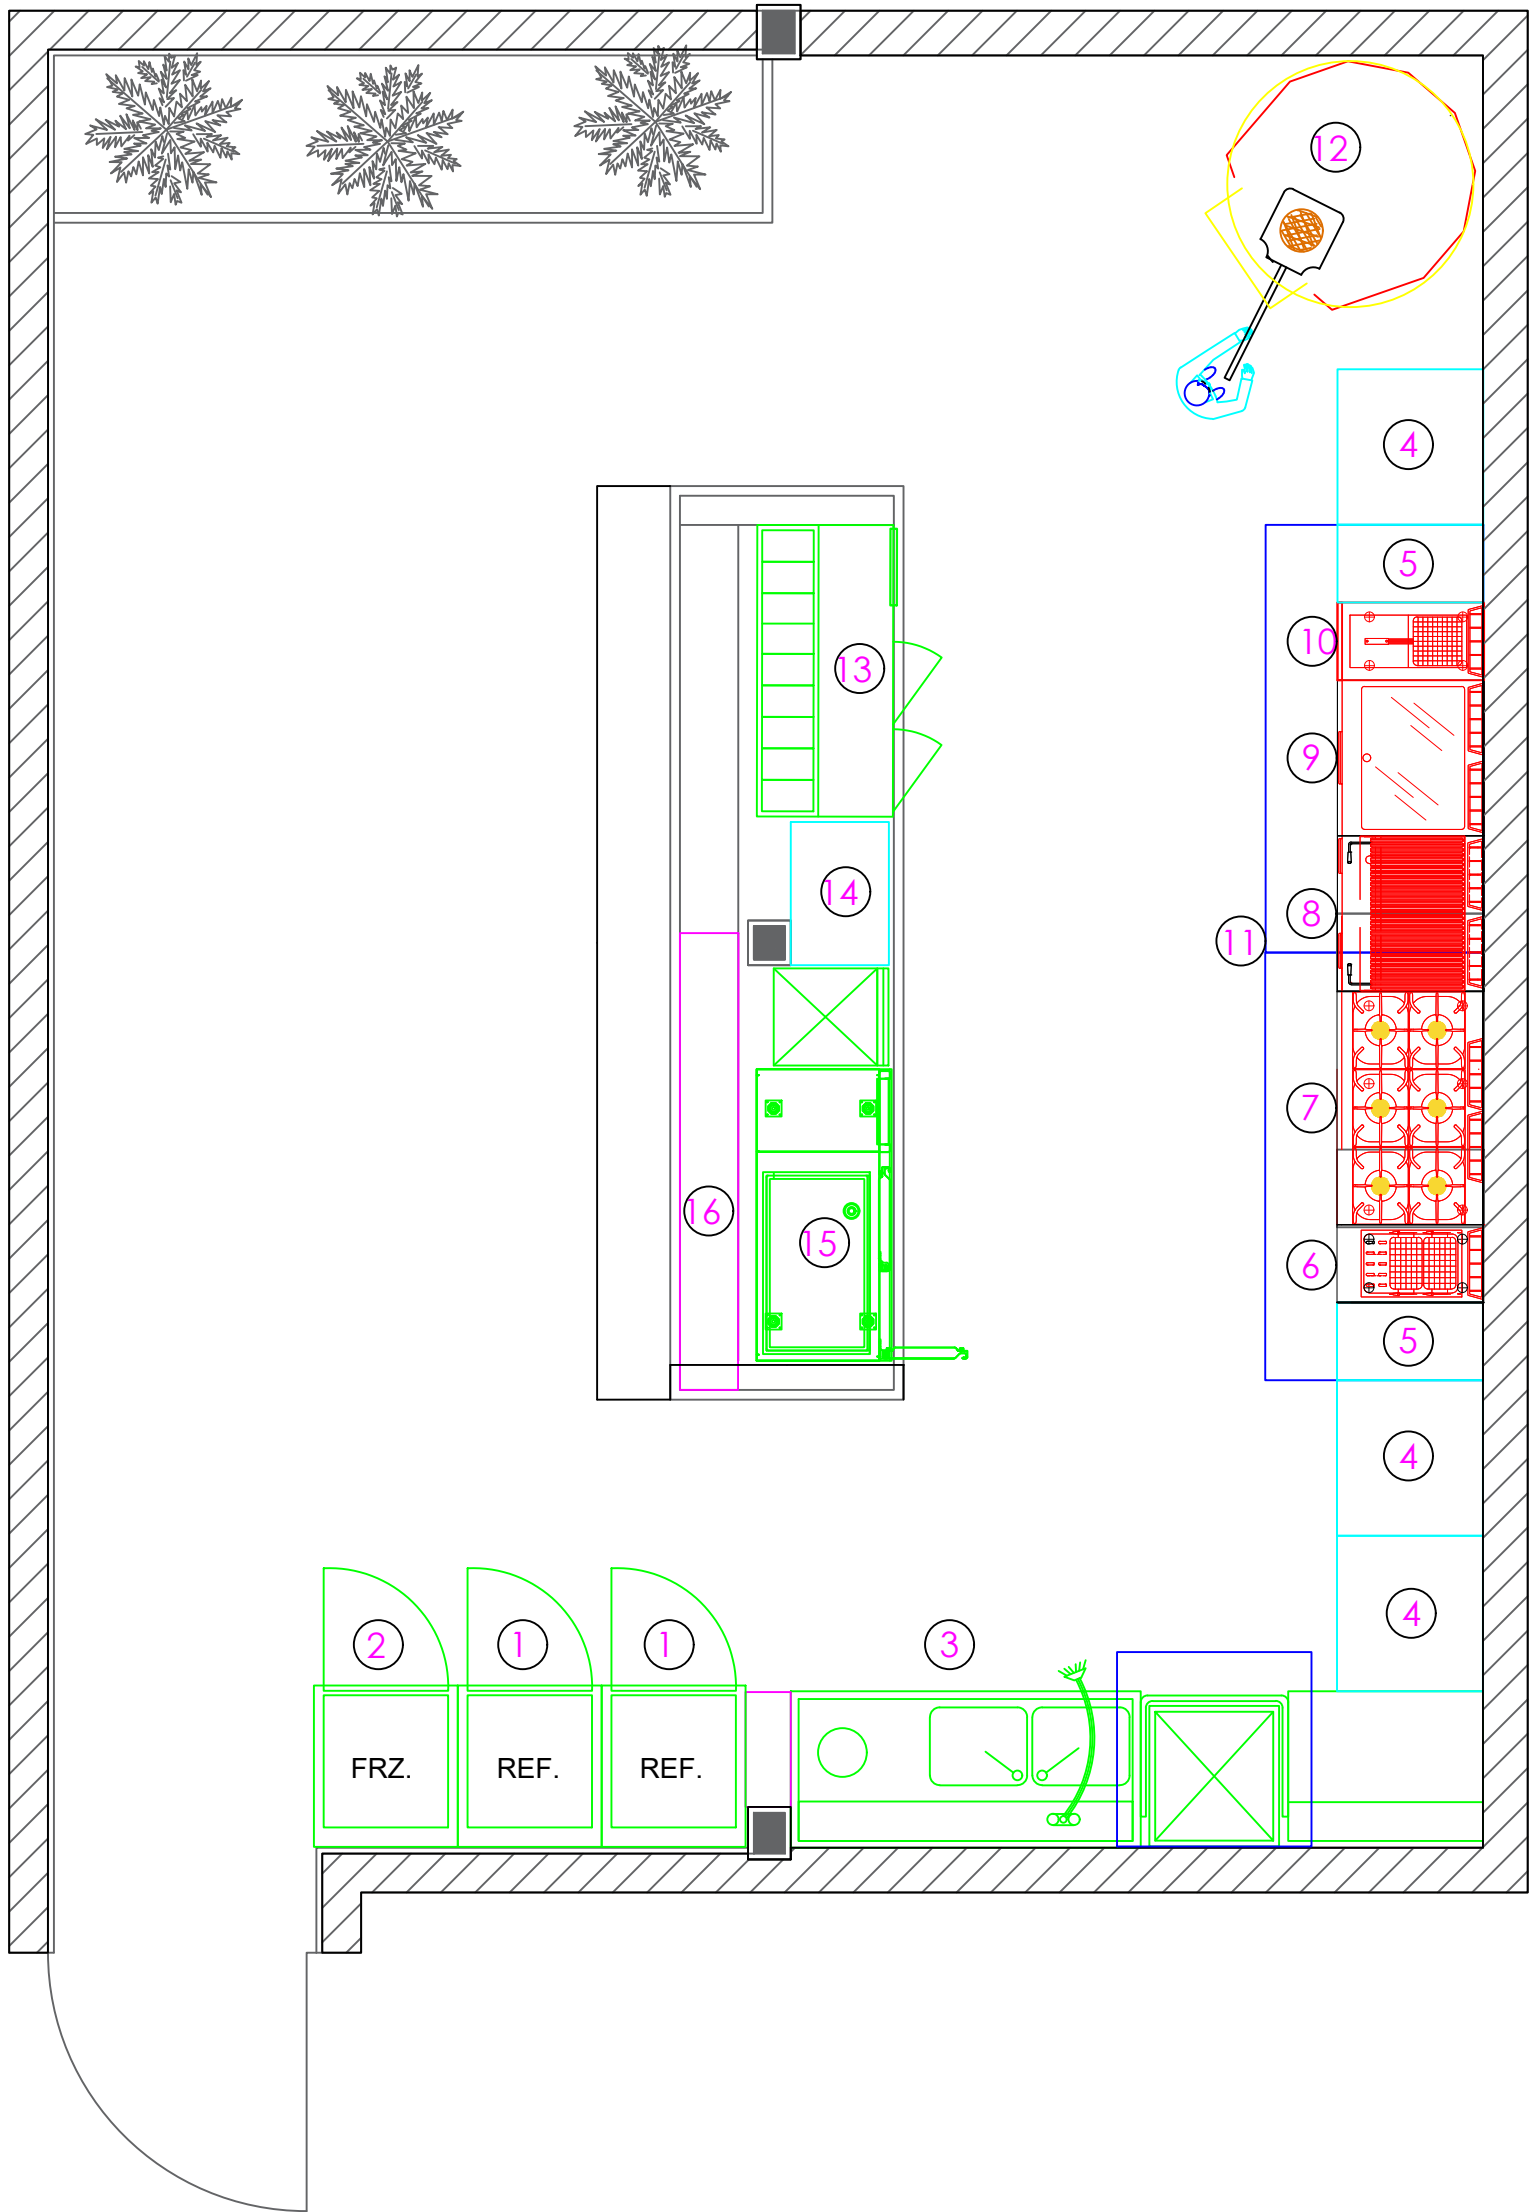

Habtoor
Kitchentech

سازمان آشپزخانه

TEL: 22694999

FAX: 22683720

DATE 1404/07/15

DRAWN BY Mr Shekari

SCALE

CHECKED BY

NO.


DRAWING TITLE

Design Layout

PROJECT & CLIENT

Golestan Showroom

APPROVED BY

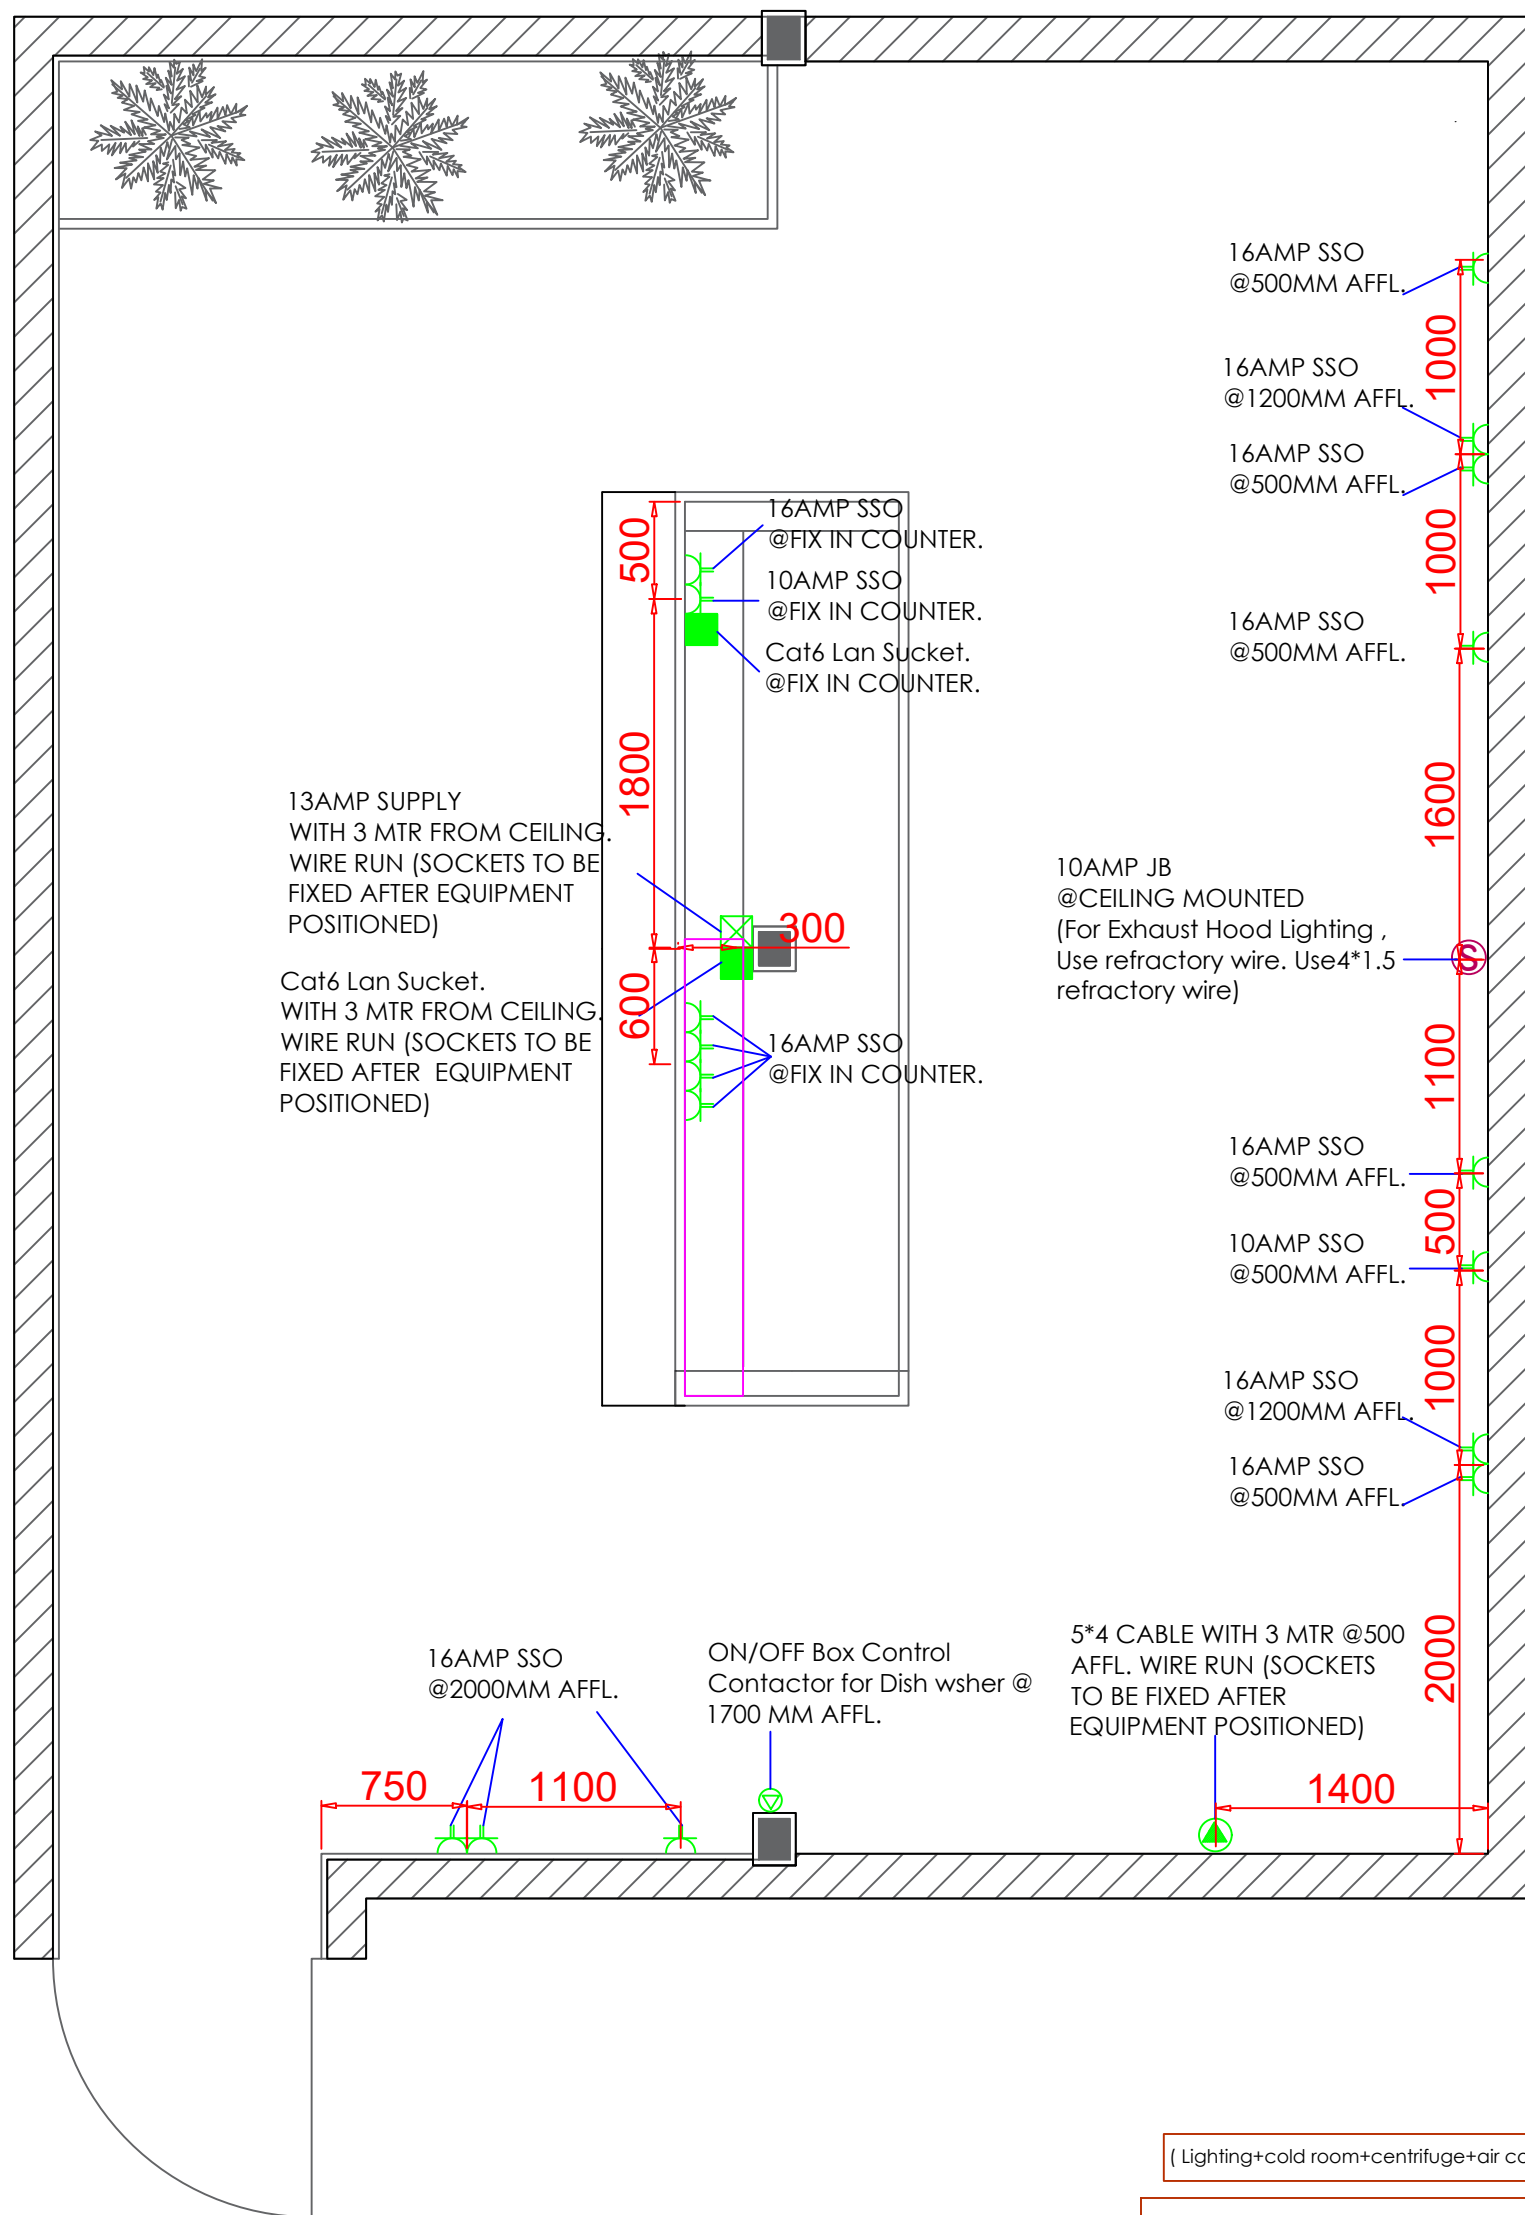


(Lighting+cold room+centrifuge+air condition ... should be added)

سیم روشنایی هود ها
این سیم ها ۳ رشته بوده و حتما نیاز به ارت دارد
و لازم به ذکر است که به دلیل جلوگیری از اتصال و
آتش سوزی جنس آن ها باید نسوز باشد.(از سیم های سیلیکونی استفاده شود).

برق برای روشنایی و تهویه جداگانه در نظر گرفته شود

Habtoor Kitchentech موسسه تخصصی آشپزخانه TEL: 22694999 FAX: 22683720		DRAWING TITLE
		Electrical Layout
PROJECT & CLIENT		Golestan Showroom
DATE 1404/07/15	DRAWN BY Ms.Golmohamadi	APPROVED BY
SCALE	CHECKED BY Mr.Shekar	
NO.		

ELECTRICAL LEGEND :		NOTE: ALL ELECTRICAL INFORMATION ARE BASED ON EQUIPMENT ACTUAL LOADING. E.E. CONTRACTOR, TO BE PROVIDED THE NECESSARY POWER REQUIREMENTS. ALL SERVICE POINTS / ROUGH-INS HAVE BEEN LOCATED AS ACCURATELY AS POSSIBLE. MECHANICAL CONTRACTOR TO CHECK AND VERIFY ACTUAL LOCATIONS WHICH MAY VARY BASED ON SITE CONDITION.
SWITCH	Ⓢ SINGLE POLE SWITCH	
SSO-13AMP	Ⓢ 13AMP. SWITCHED SOCKET OUTLET SINGLE	GENERAL: 1. ELECTRICAL CONTRACTOR TO PROVIDE WATER-TIGHT, GREASE PROOF CONDUITS, SWITCHES/ISLATORS AND JUNCTION BOXES- (IF NECESSARY)WITH 1 METRE WIRE RUN. 2. PLUMBING CONTRACTOR MUST PROVIDE ALL WATER INLETS WITH ANGLE VALVE. 3. H.V.A.C. CONTRACTOR TO PROVIDE DUCT WORK AND FAN FOR EXHAUST HOODS REQUIREMENTS AND CO ORDINATE E.E. REQUIREMENT FOR THE SAME 4. MECHANICAL CONTRACTOR TO PROVIDE NECESSARY FLOOR TRAPS AND GREASE TRAP
SSO-19AMP	Ⓢ 19AMP. SWITCHED SOCKET OUTLET SINGLE	
E220V -JB	Ⓢ 220V JUNCTION BOX W/ GROUND	
E380V	Ⓢ 380V MALE/FEMALE SOCKET + N+E	
E220V	Ⓢ MALE/FEMALE SOCKET FROM CEILING	
AFFL.	- ABOVE FINISHED FLOOR LEVEL	

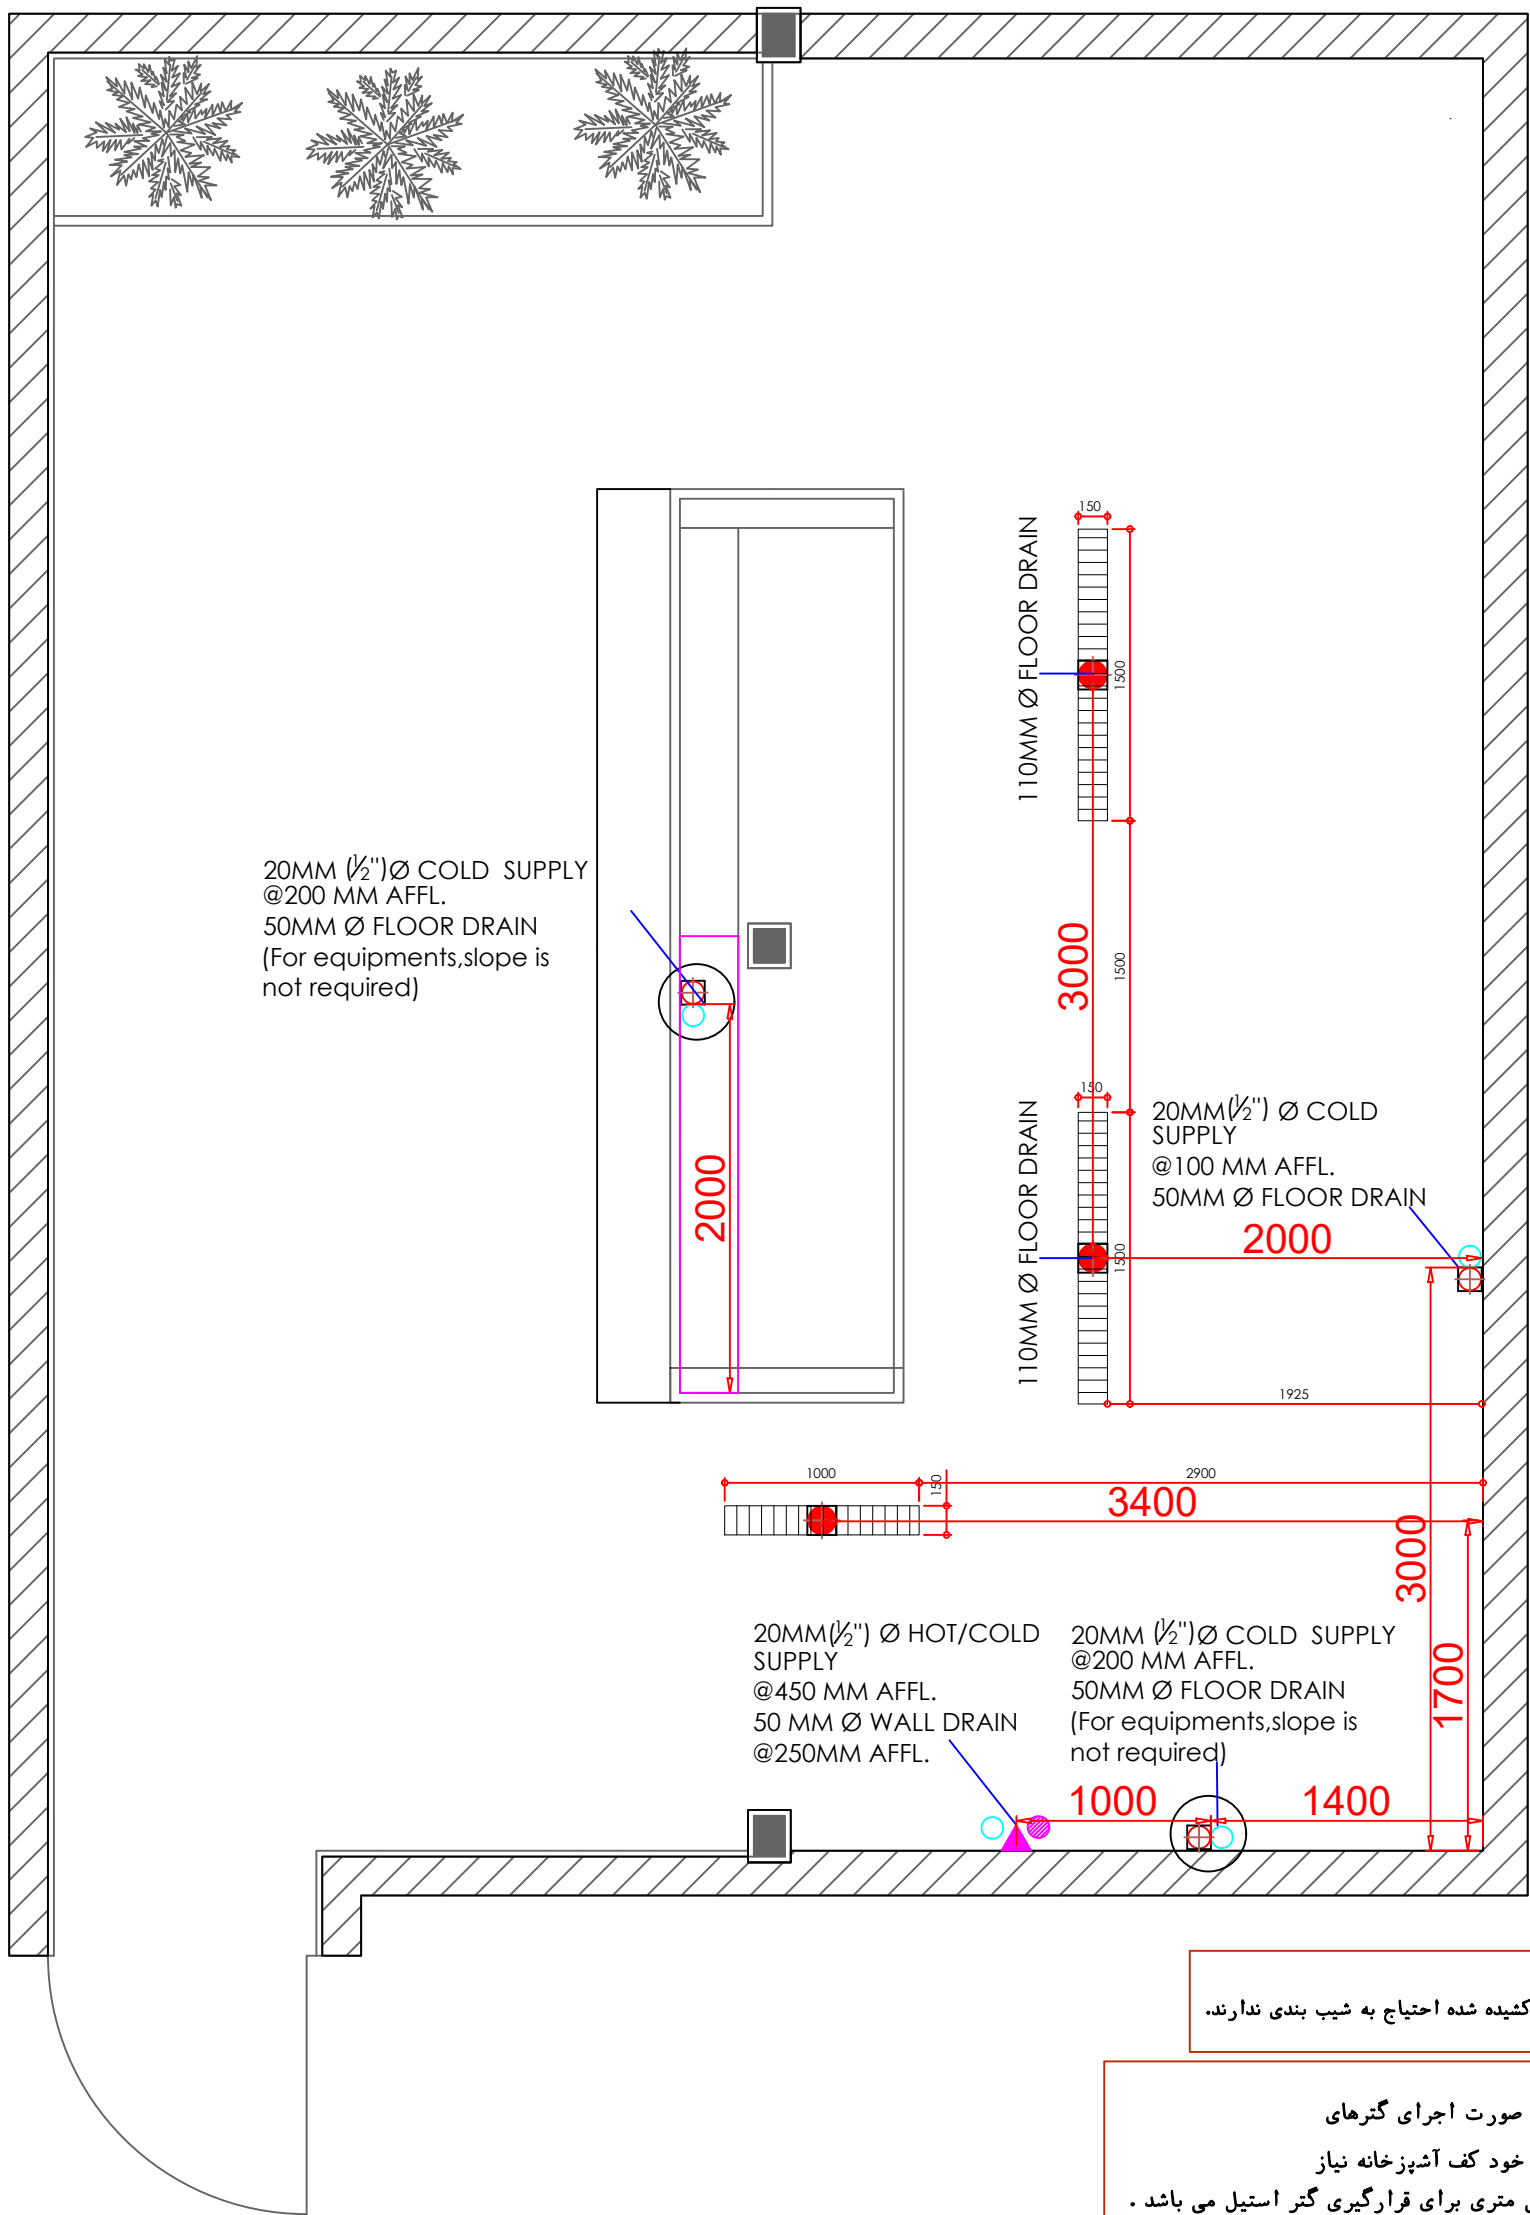


توجه
تخلیه هایی که دور آنها خط کشیده شده احتیاج به شیب بندی ندارند.

لازم به ذکر است که در صورت اجرای گترهای
کف با متریال سرامیک یا خود کف آشپزخانه نیاز
به اجرای یک لبه ۲ سانتی متری برای قرارگیری گتر استیل می باشد .

فاصله لوله آب و درین از دیواره جلو کانتر ۱۰ سانتی متر می باشد
لازم به ذکر است که این فاصله مهم بوده و بعد از اجرای دیواره
کانتر نباید تغییر کند.

Habtoor Kitchentech سازمان آشپزخانه		DRAWING TITLE	
		Plumbing Layout	
TEL: 22694999 FAX: 22683720		PROJECT & CLIENT	
		Golestan Showroom	
DATE 1404/07/15	DRAWN BY Ms.Golmohamadi	APPROVED BY	
SCALE	CHECKED BY Mr.Shekari		
NO.			

NOTE: ALL ELECTRICAL INFORMATION ARE BASED ON EQUIPMENT ACTUAL LOADING. E.E. CONTRACTOR TO BE PROVIDED THE NECESSARY POWER REQUIREMENTS. ALL SERVICE POINTS / ROUGH-INS HAVE BEEN LOCATED AS ACCURATELY AS POSSIBLE. MECHANICAL CONTRACTOR TO CHECK AND VERIFY ACTUAL LOCATIONS WHICH MAY VARY BASED ON SITE CONDITION. GENERAL: 1. ELECTRICAL CONTRACTOR TO PROVIDE WATER-TIGHT, GREASE PROOF CONDUITS, SWITCHES/ISLATORS AND JUNCTION BOXES- (IF NECESSARY)WITH 1 METRE WIRE RUN. 2. PLUMBING CONTRACTOR MUST PROVIDE ALL WATER INLETS WITH ANGLE VALVE. 3. H.V.A.C. CONTRACTOR TO PROVIDE DUCT WORK FOR EXHAUST HOODS REQUIREMENTS. 4. MECHANICAL CONTRACTOR TO PROVIDE NECESSARY FLOOR TRAPS AND GREASE TRAP	LEGEND: ⊗ GAS OUTLET ● 20mm# HOT WATER SUPPLY (W/ANGLE VALVE) ○ 20mm# COLD WATER SUPPLY (W/ANGLE VALVE) ▷ 50mm# WALL DRAIN ■ 100mm# FLOOR TRAP ⊞ 75mm# FLOOR DRAIN (Used for equipments , slope is not required) AFL ABOVE FINISH FLOOR LINE

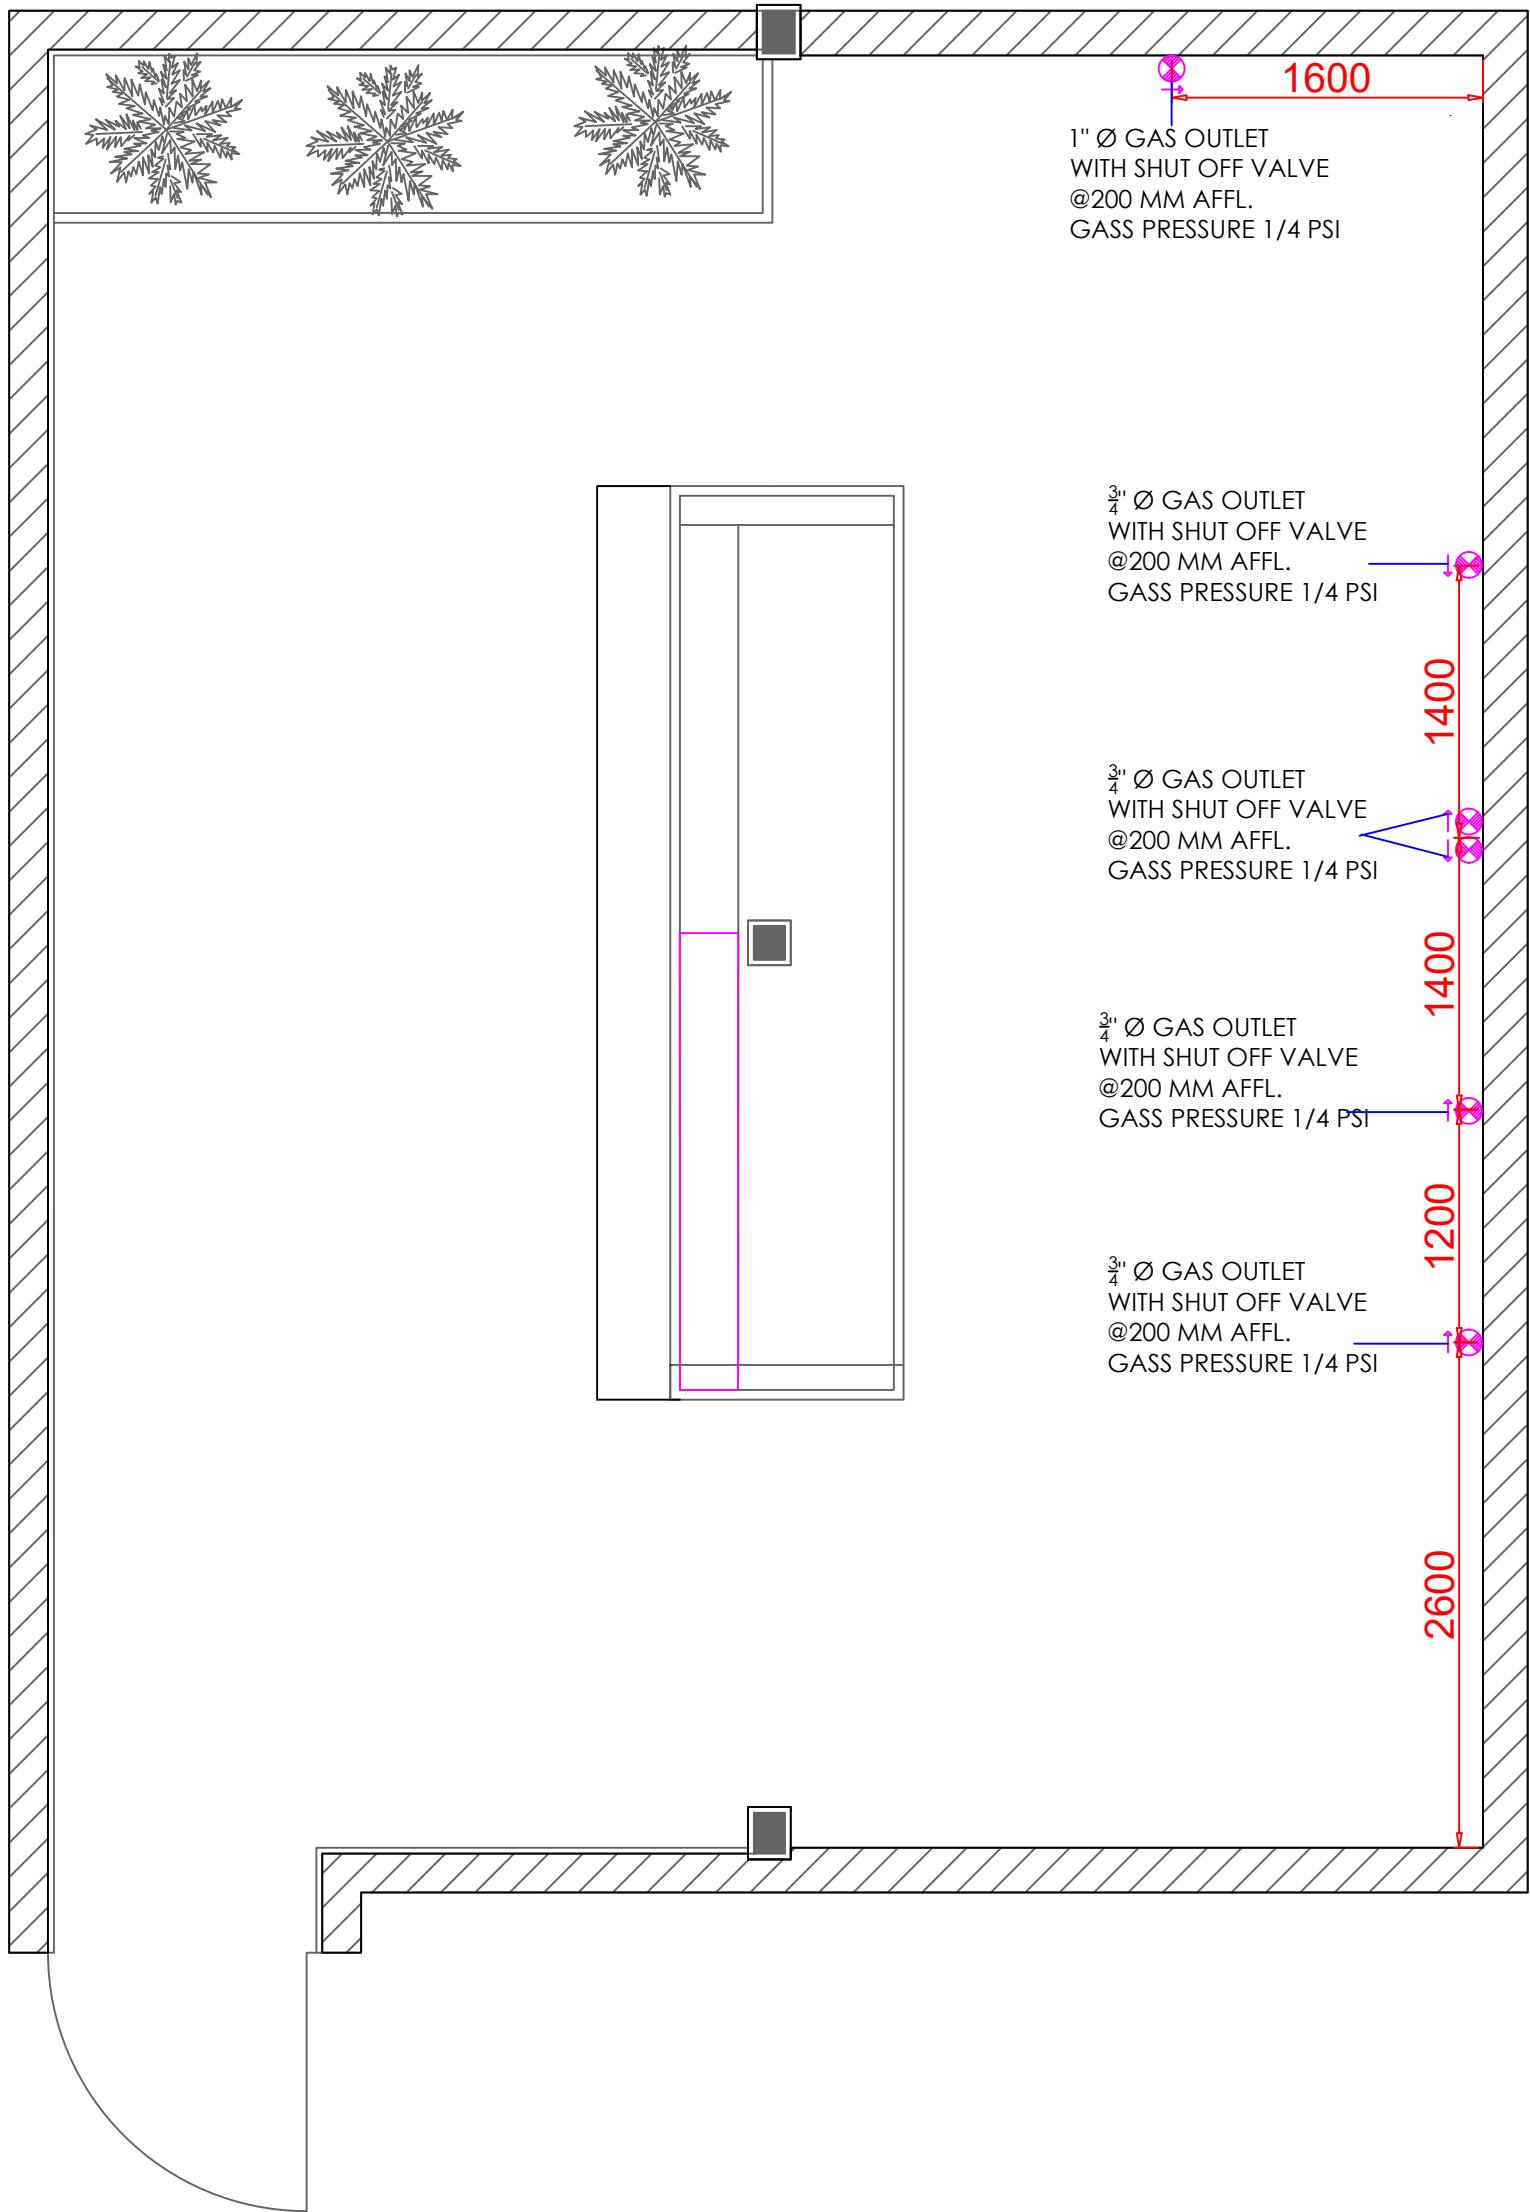

نوجه مهم در صورت اجرای انشعاب اصلی گاز به صورت رو کار حتما توجه شود که از قسمت هود ها انتقال داده نشود

Habtoor
Kitchentech

سازمان آشپزخانه

TEL: 22694999

FAX: 22683720

DATE 1404/07/15

DRAWN BY Ms.Golmohamadi

SCALE

CHECKED BY

Mr.Shekar

NO.

DRAWING TITLE

Gas Layout

PROJECT & CLIENT

Golestan Showroom

APPROVED BY


NOTE: ALL ELECTRICAL INFORMATION ARE BASED ON EQUIPMENT ACTUAL LOADING. E.E. CONTRACTOR TO BE PROVIDED THE NECESSARY POWER REQUIREMENTS. ALL SERVICE POINTS / ROUGH-INS HAVE BEEN LOCATED AS ACCURATELY AS POSSIBLE. MECHANICAL CONTRACTOR TO CHECK AND VERIFY ACTUAL LOCATIONS WHICH MAY VARY BASED ON SITE CONDITION.

GENERAL:

1. ELECTRICAL CONTRACTOR TO PROVIDE WATER-TIGHT, GREASE PROOF CONDUITS, SWITCHES/ISOLATORS AND JUNCTION BOXES- (IF NECESSARY) WITH 1 METRE WIRE RUN.
2. PLUMBING CONTRACTOR MUST PROVIDE ALL WATER INLETS WITH ANGLE VALVE.
3. H.V.A.C. CONTRACTOR TO PROVIDE DUCT WORK FOR EXHAUST HOODS REQUIREMENTS.
4. MECHANICAL CONTRACTOR TO PROVIDE NECESSARY FLOOR TRAPS AND GREASE TRAP

LEGEND:

- ⊗ GAS OUTLET
- 20mm# HOT WATER SUPPLY (W/ANGLE VALVE)
- 20mm# COLD WATER SUPPLY (W/ANGLE VALVE)
- ▽ 50mm# WALL DRAIN
- 100mm# FLOOR TRAP
- ⊠ 75mm# FLOOR DRAIN
- AFFL ABOVE FINISH FLOOR LINE

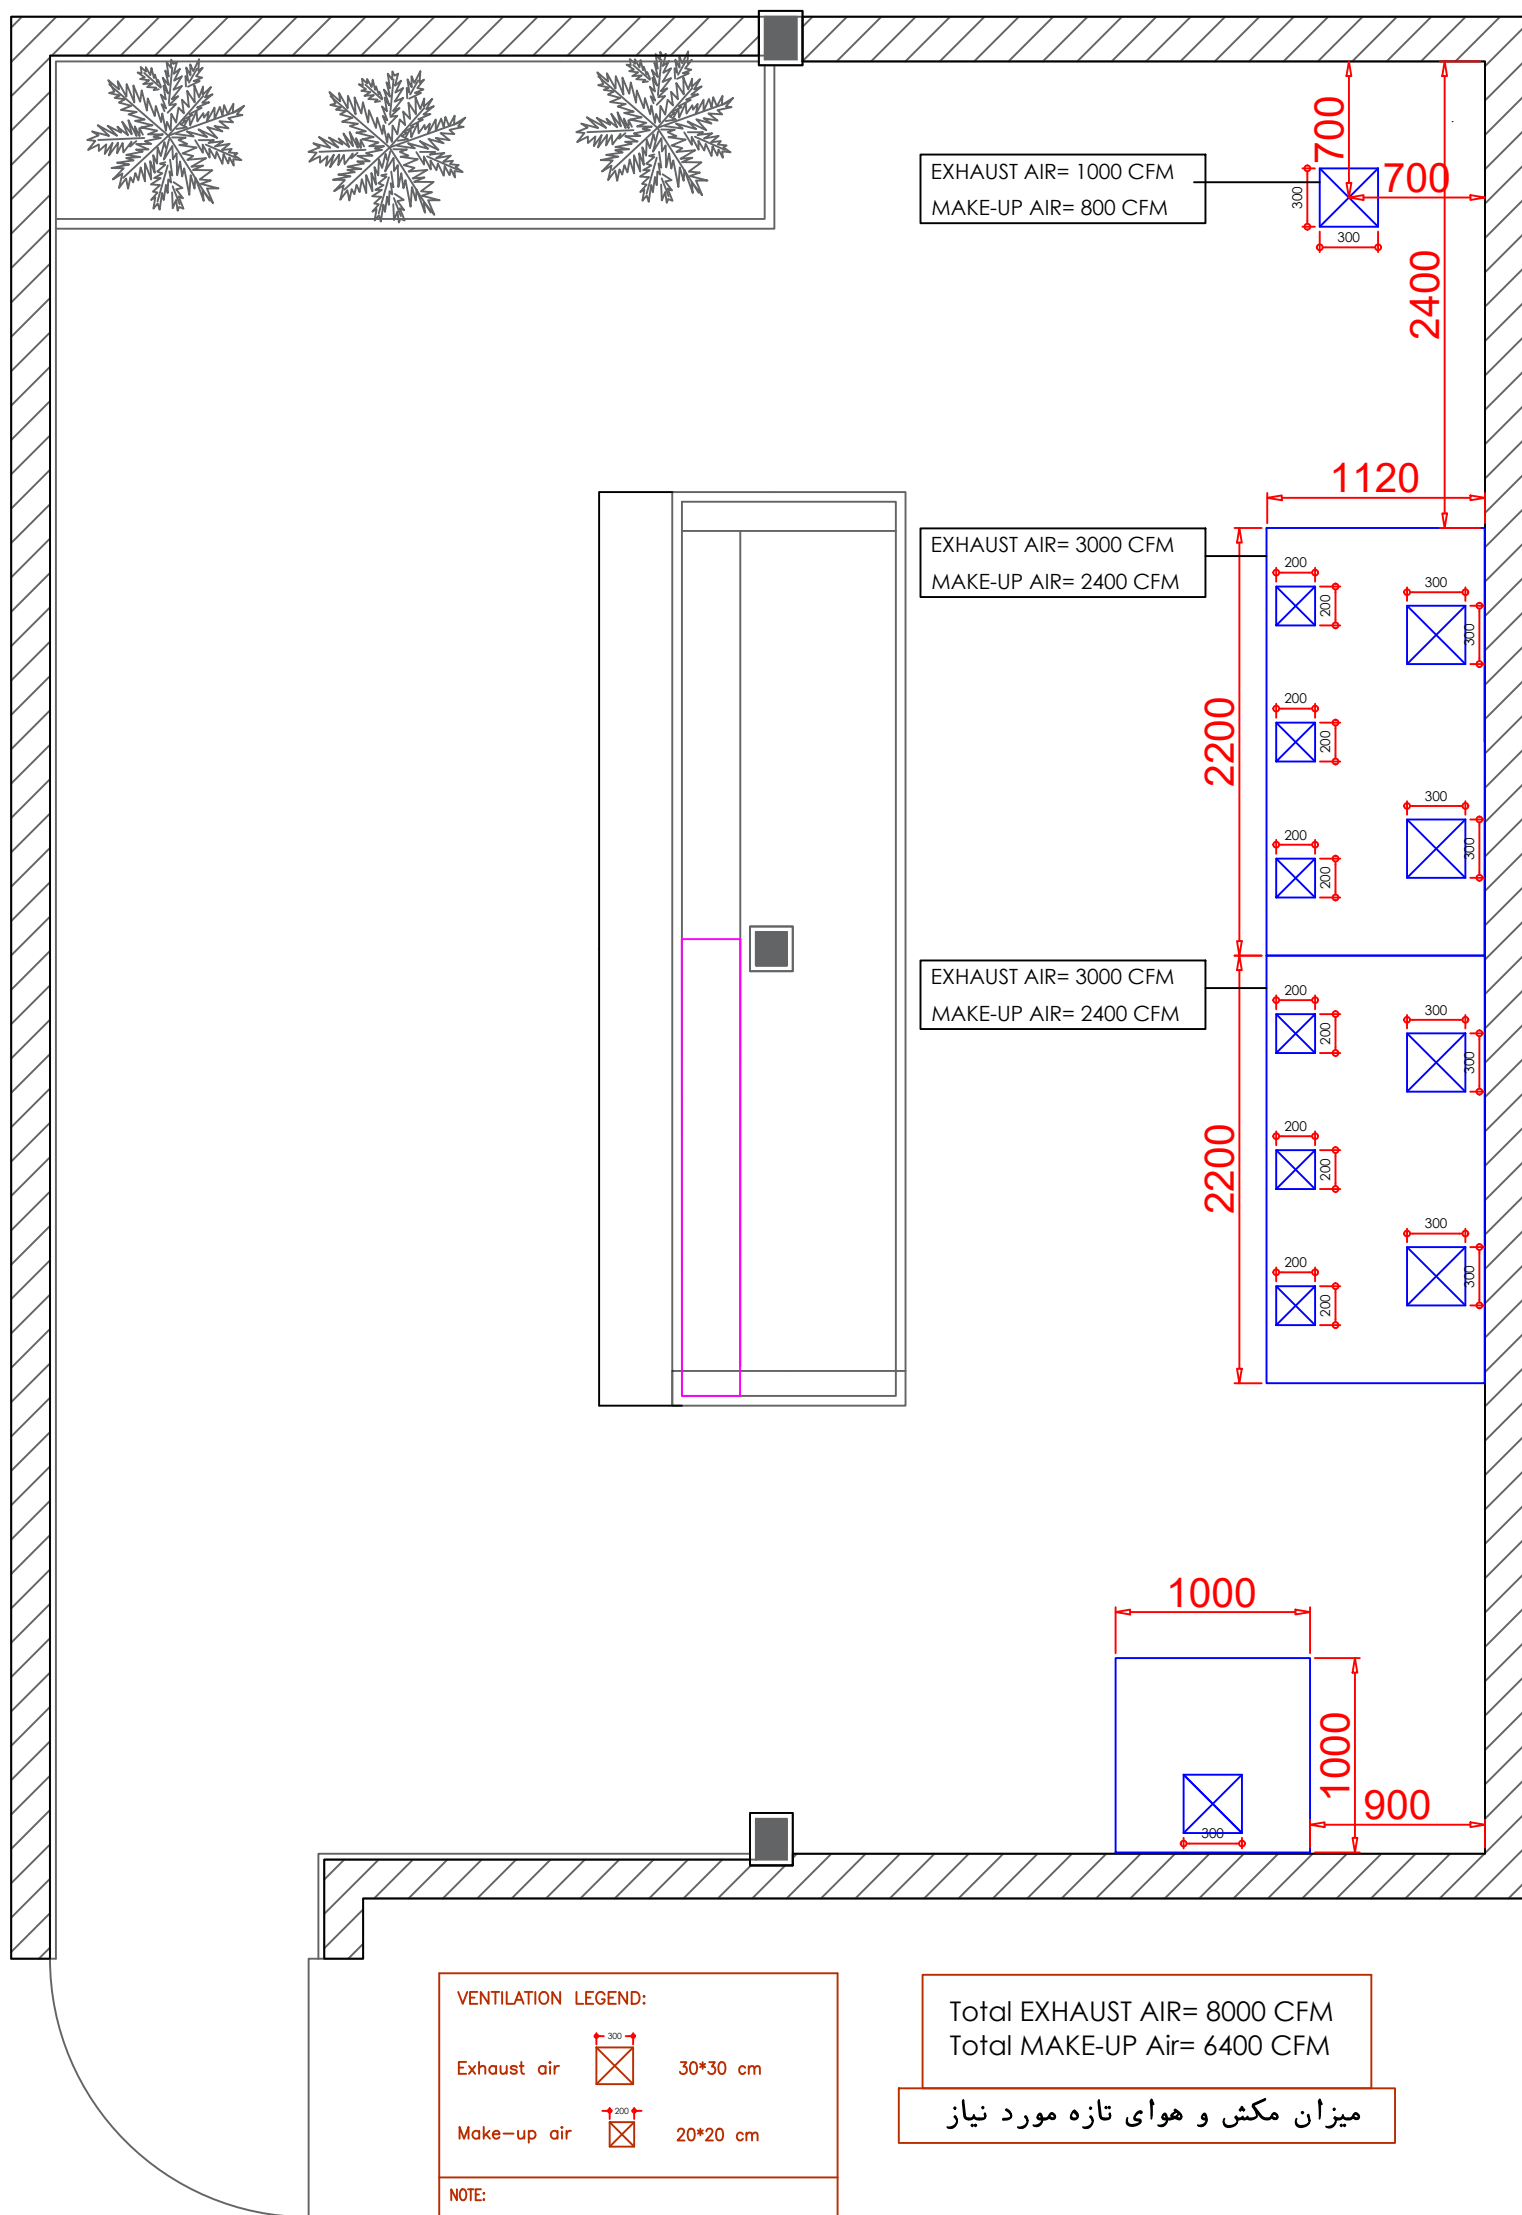

با توجه به وزن بالای هود ها برای اجرای دیوار های پشت هود باید از متریال محکم مانند آجر و سیمان استفاده شود.

برای اجرای هودهای جزیره نیازمند یک کلاف فلزی در بالای هودها برای نصب زنجیرها به آن می باشد لازم به ذکر است که ابعاد کلاف ها دقیقا به اندازه هودها می باشد.

با توجه به نك جدا ره بودن هودهای خط پخت مقدار هوای تازه و ورودی آشپزخانه در داخل خط آشپزخانه تزریق می گردد. انتخاب لوکیشن و سائز دریچه ها با مجری می باشد.

Habtoor
Kitchentech

مسابك آشپزخانه

TEL: 22694999

FAX: 22683720

DATE 1404/07/15

DRAWN BY Ms.Golmohamadi

APPROVED BY

SCALE

CHECKED BY

Mr.Shekar

NO.

PROJECT & CLIENT

Golestan Showroom

DRAWING TITLE

Ventilation Layout